


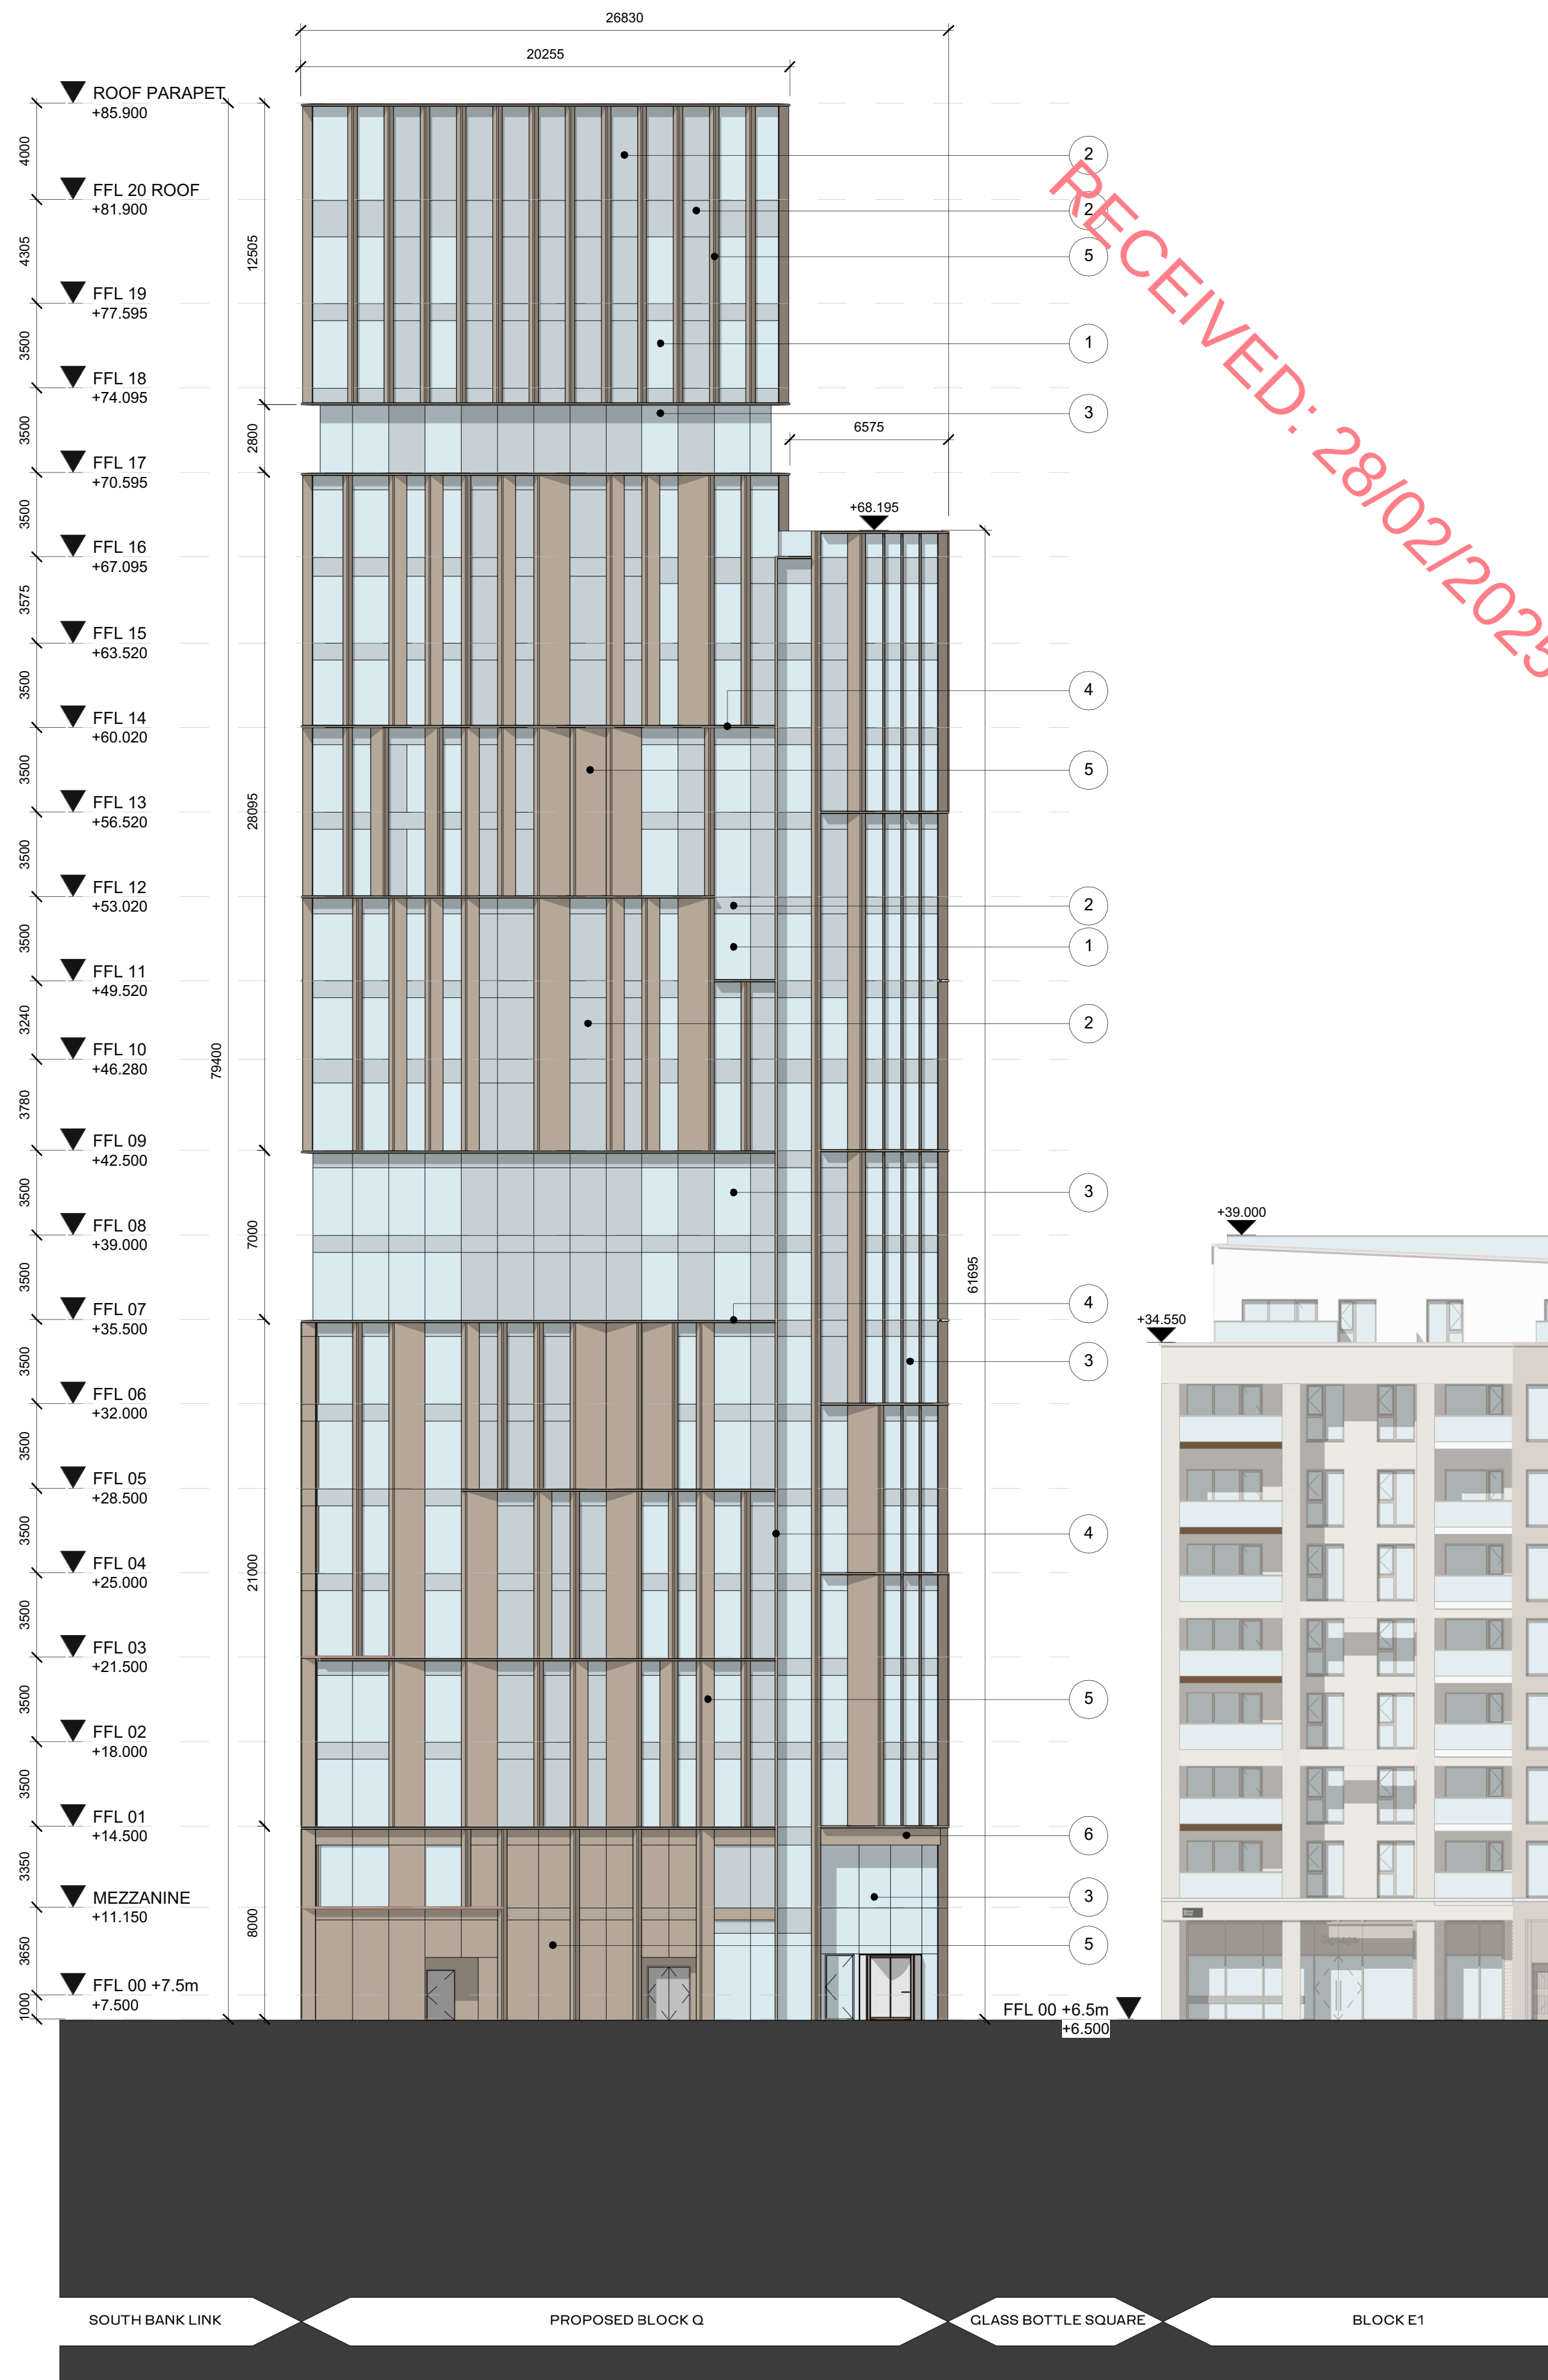


1 SOUTH ELEVATION
1 : 200



2 NORTH ELEVATION
1 : 200

ALL DIMENSIONS TO BE CHECKED ON SITE
NO DIMENSIONS TO BE SCALED FROM THIS DRAWING
READ IN CONJUNCTION WITH RELEVANT CONSULTANT'S DRAWINGS

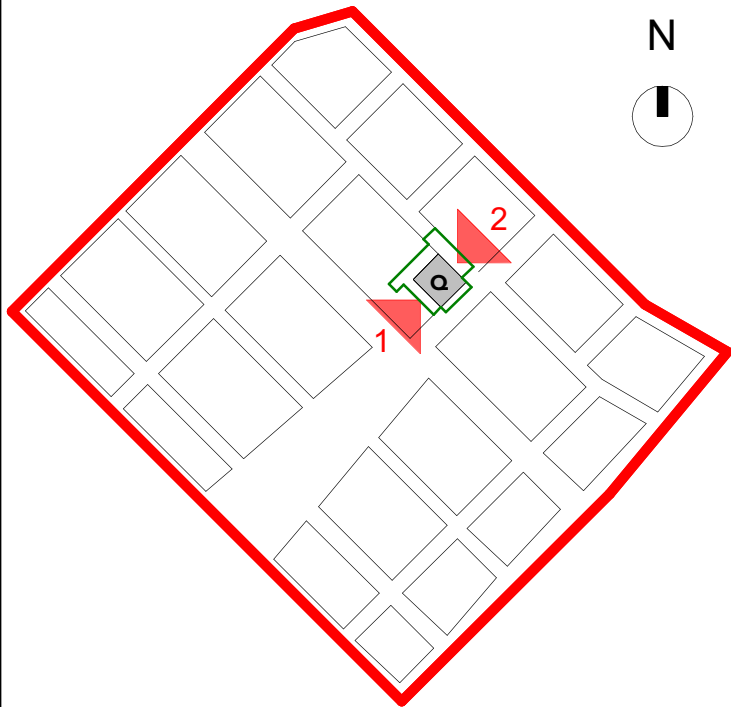

Masterplan Site Area_15.06ha
Application Boundary_0.21ha

MATERIALS LEGEND	
1	VISION GLAZING
2	NON-VISION GLAZING
3	UNITISED CURTAIN WALLING SYSTEM
4	FINIS WITH BRONZE COLOUR FINISH
5	SOLID PANELS WITH BRONZE COLOUR FINISH
6	SPANDREL PANELS WITH BRONZE COLOUR FINISH
7	DECORATIVE SCREEN

0 4 8 12 16 20m
GRAPHIC SCALE: 1:200

REV	DATE	DESCRIPTION	OS	SS
P01	31/01/2025	ISSUED FOR PLANNING	OS	SS
REV	DATE	DESCRIPTION	CKH	DRN

STATUS CODE DESCRIPTION
ISSUED FOR PLANNING APPROVAL

CLIENT
PEMBROKE BEACH DAC

PROJECT
PHASE 2B - BLOCK Q

DRAWING
ELEVATIONS
NORTH & SOUTH ELEVATIONS

PROJECT NUMBER 951202	DATE 31/01/2025
SCALE@ A1: 1 : 200	DRAWN/CHECKED: SSI/OS

STATUS CODE: A1	DRAWING NUMBER PEM-HJL-P2B-ZZ-DR-A-2001	REVISION P01
--------------------	--	-----------------

Henry J Lyons

Architecture + Interiors
henryjlyons.com
+353 1 888 3333
info@henryjlyons.com
51-54 Pearse Street
Dublin D02 KA66