



RECEIVED: 26/02/2025

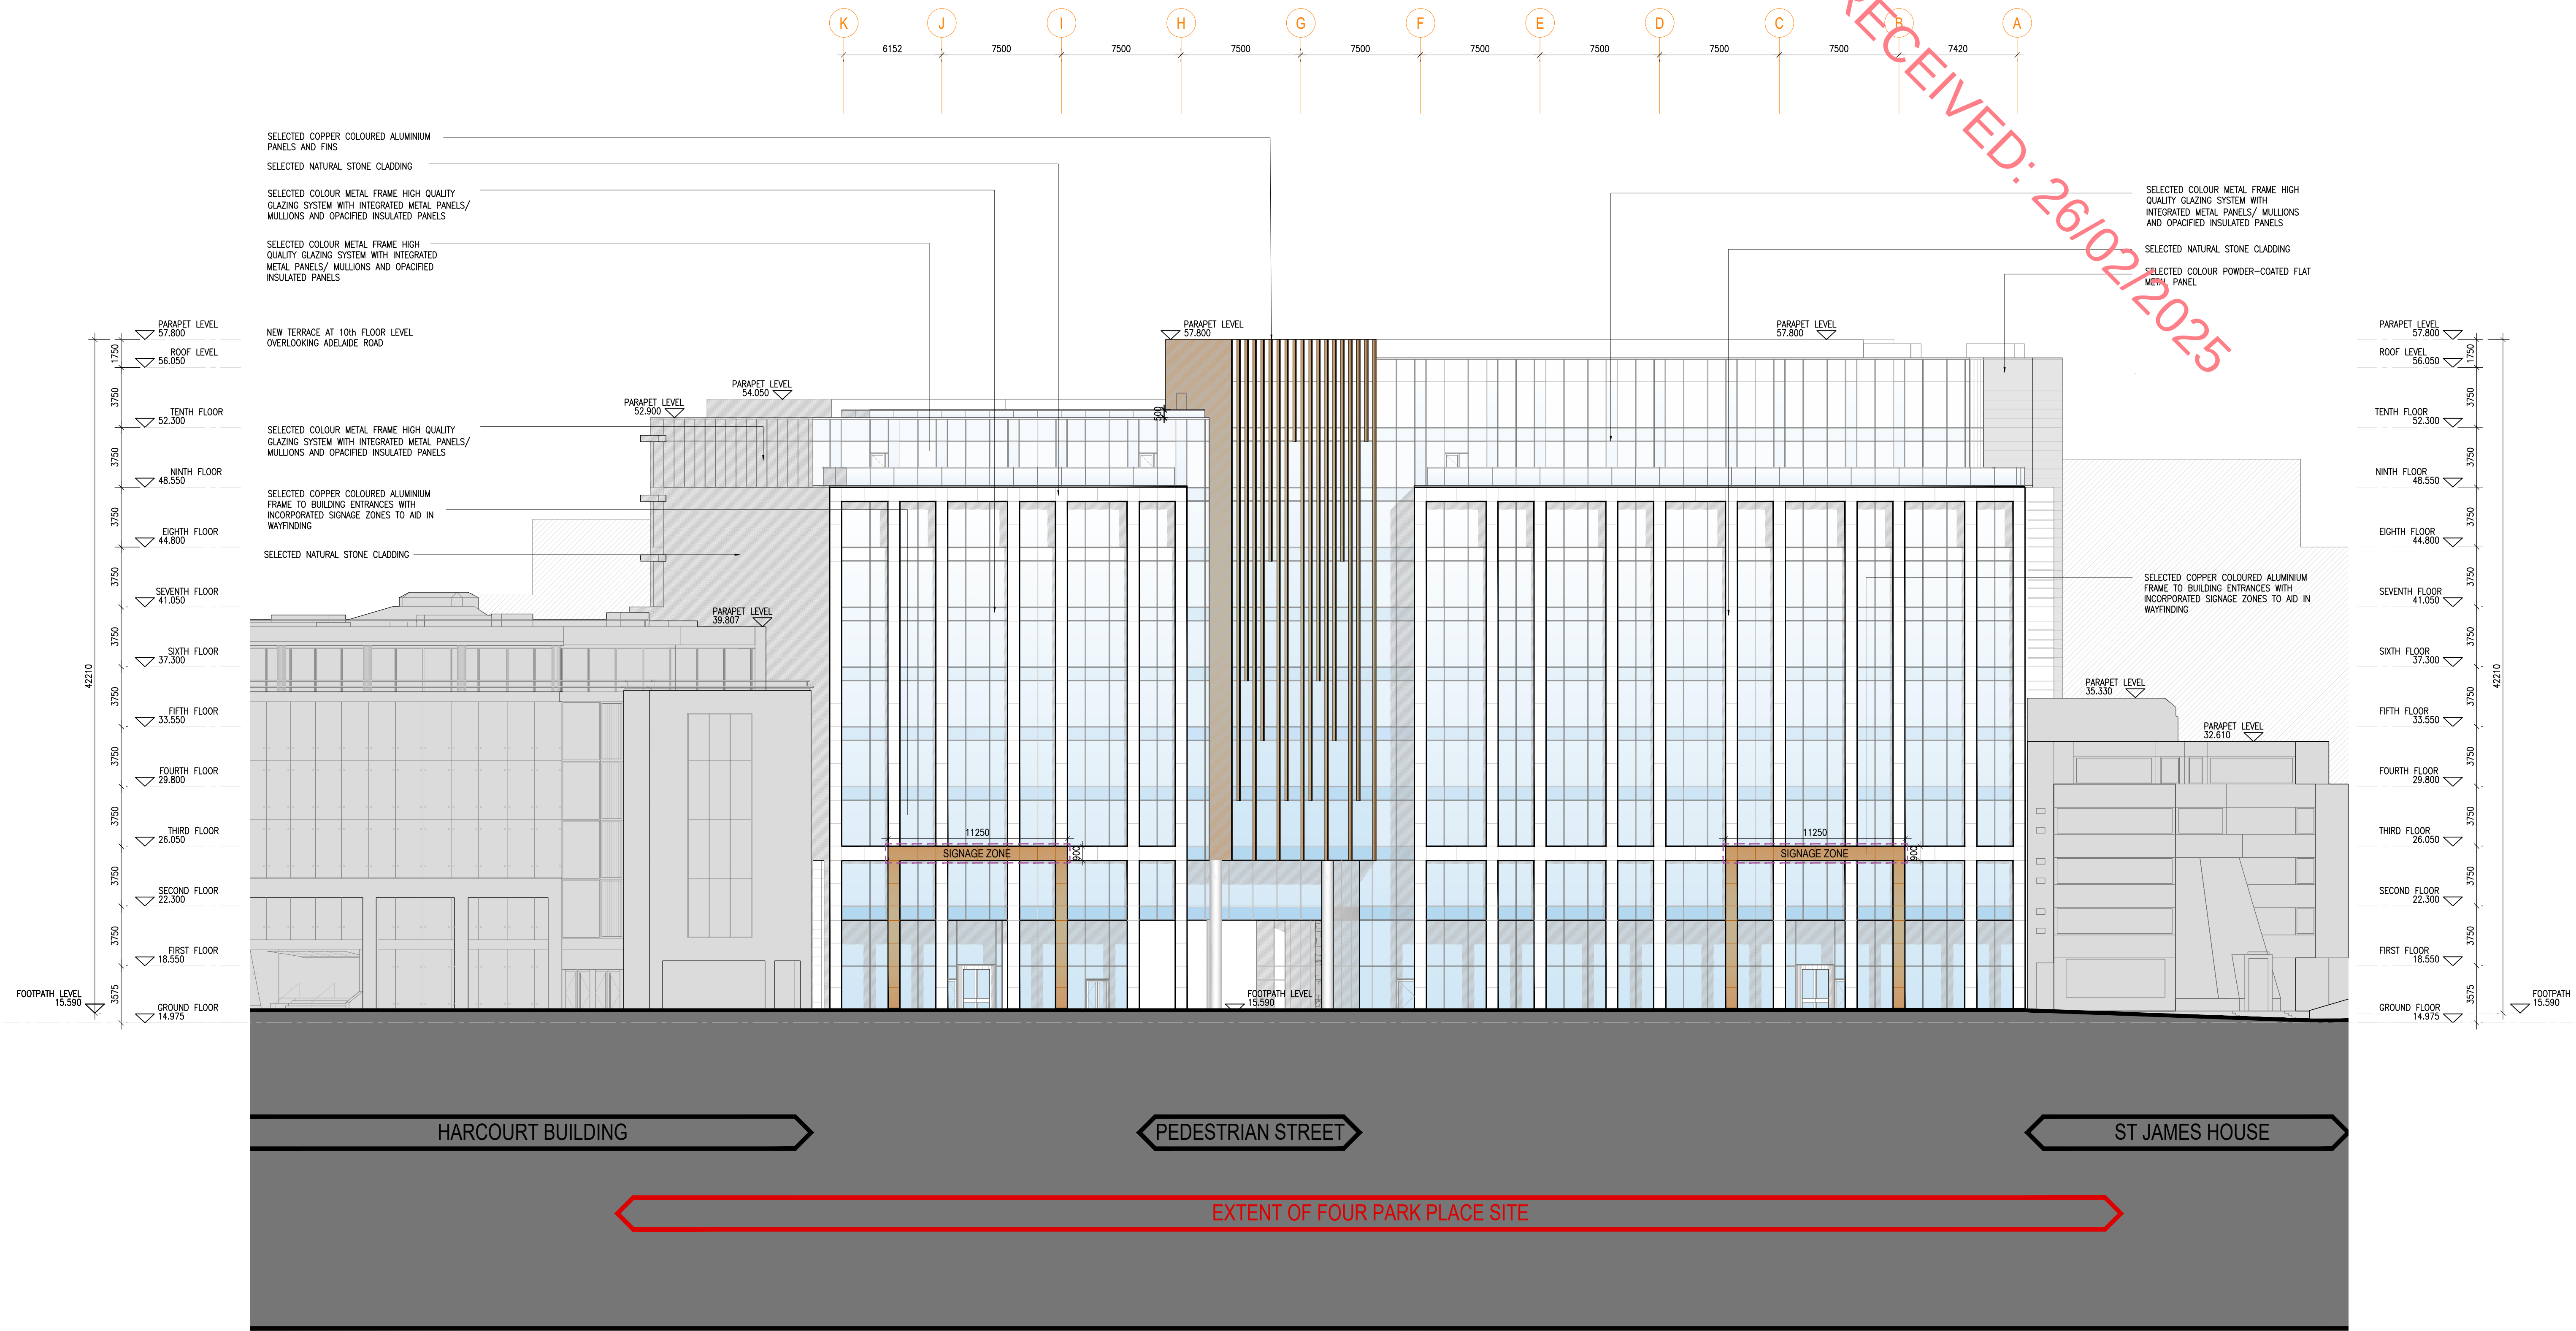

PERMITTED SOUTH ELEVATION
1:200
NO WORKS PROPOSED

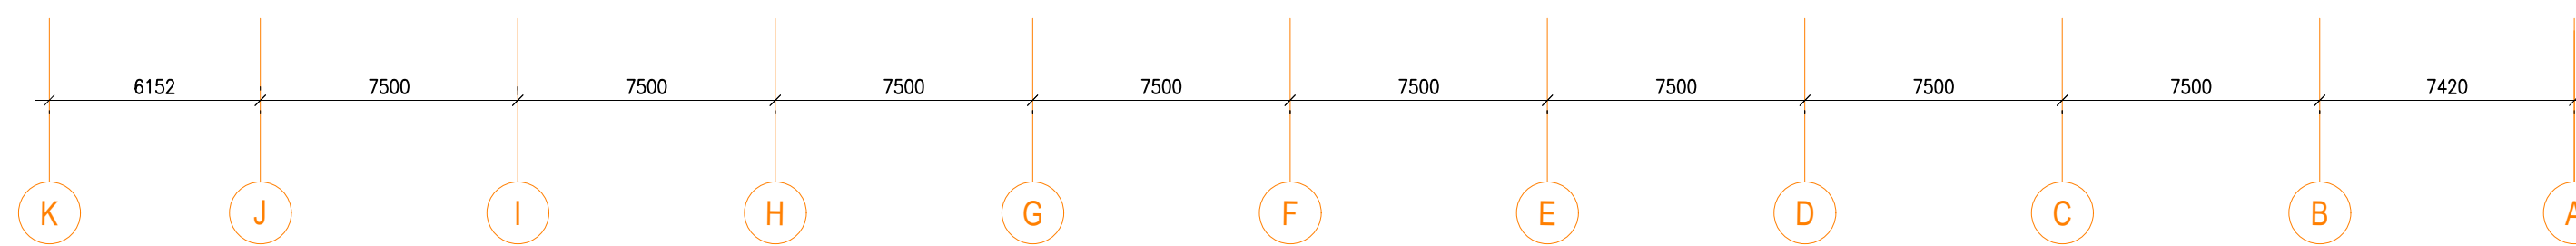

Legend

- AMENDMENTS TO PERMITTED SCHEME
- SIGNAGE ZONE

Key Plan

North

Notes	Issue Status	No.	Date	Revision	Initials
1. Copyright Reserved	Progress	A	20.02.2025	ISSUED FOR PLANNING	DMG
2. Work to figure dimensions only. Do not scale drawing	Planning Application				
3. The contractor is responsible for checking all levels and dimensions on site and shall refer all discrepancies to the Architect	Fire Cert				
4. Where appropriate, for details of r.c. structure, or mechanical and electrical details, see Engineers drawings	Tender				
5. Proprietary items shall be fixed in strict accordance with manufacturers instructions	Construction				
6. Sizes of proprietary items shall be checked with manufacturer	As Built				
7. The contractor shall be responsible for the coordination of structure, finishes and services	Information Only				
17.48.57	Permitted Elevations.dwg				

Project

FOUR PARK PLACE DEVELOPMENT, ADELAIDE ROAD, FOR SUNNY QUARTER DAC.

Drawing Title

South Elevation to Adelaide Road - Permitted

Drawing No

6177(D)-007

Scale

1:200 @ A1

Rev

A

Drawn

DMG

Date

April 2022

6-7 HARCOURT TERRACE, DUBLIN 2, IRELAND
t +353-1-618 2400 f +353-1-676 7396
www.bkd.ie

bkdarchitects
BURKE-KENNEDY DOYLE