



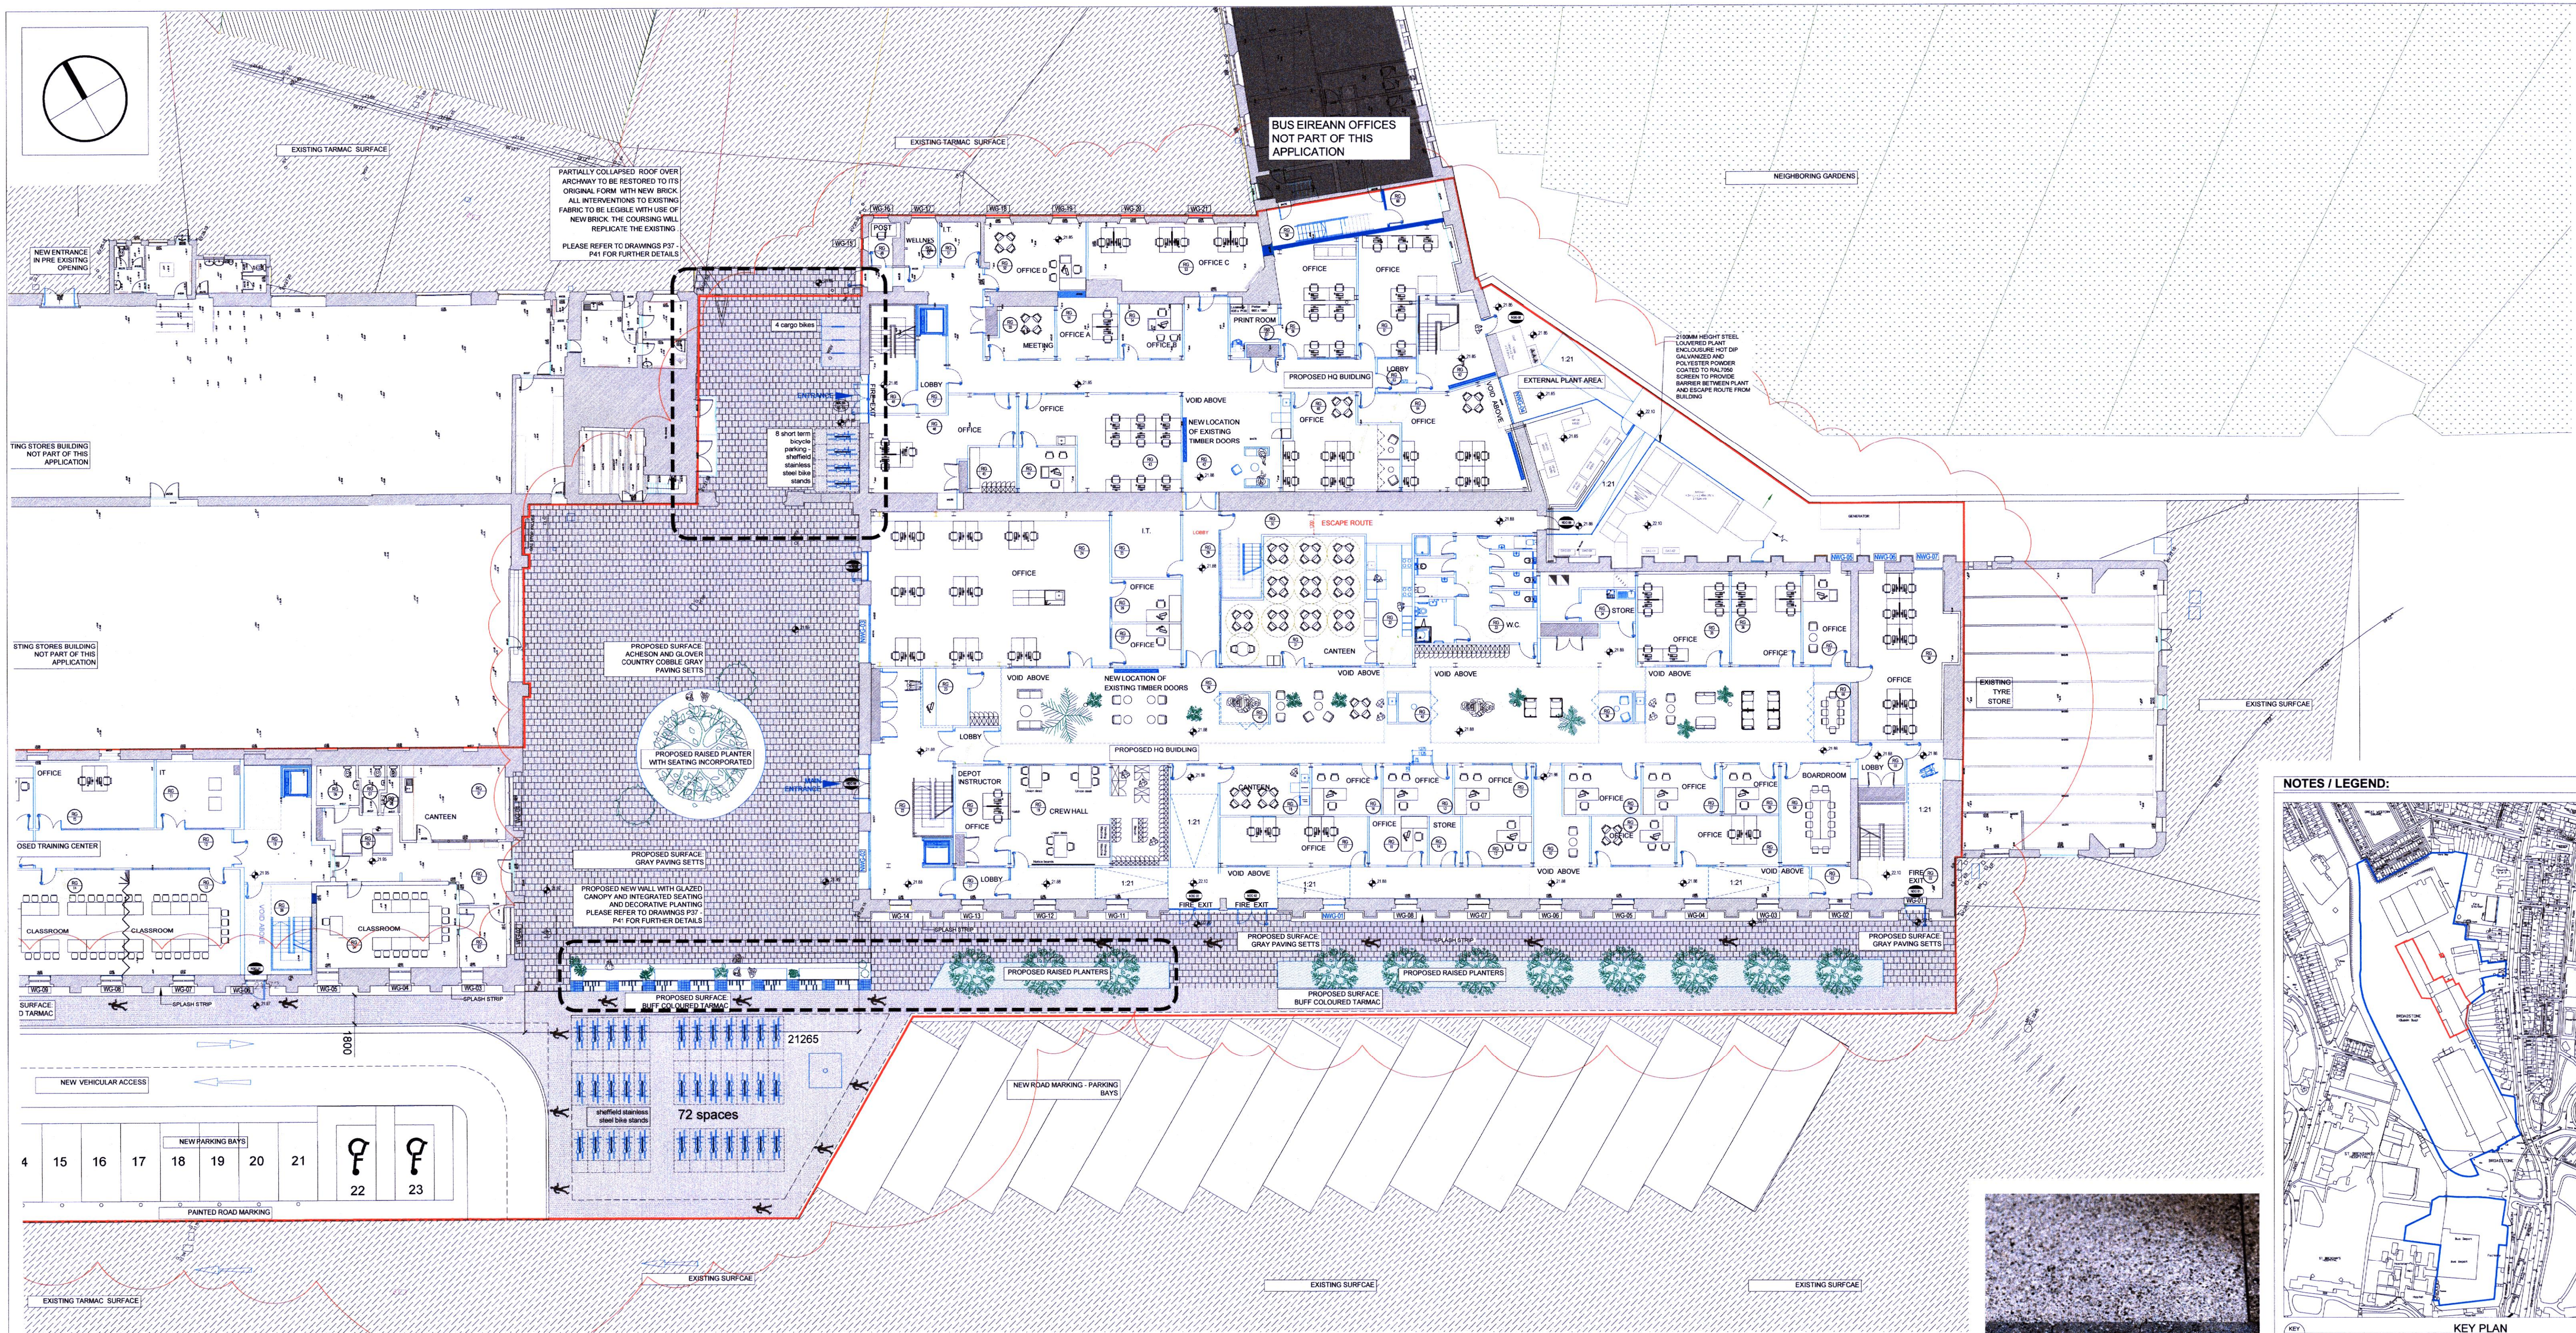


NOTES / LEGEND:

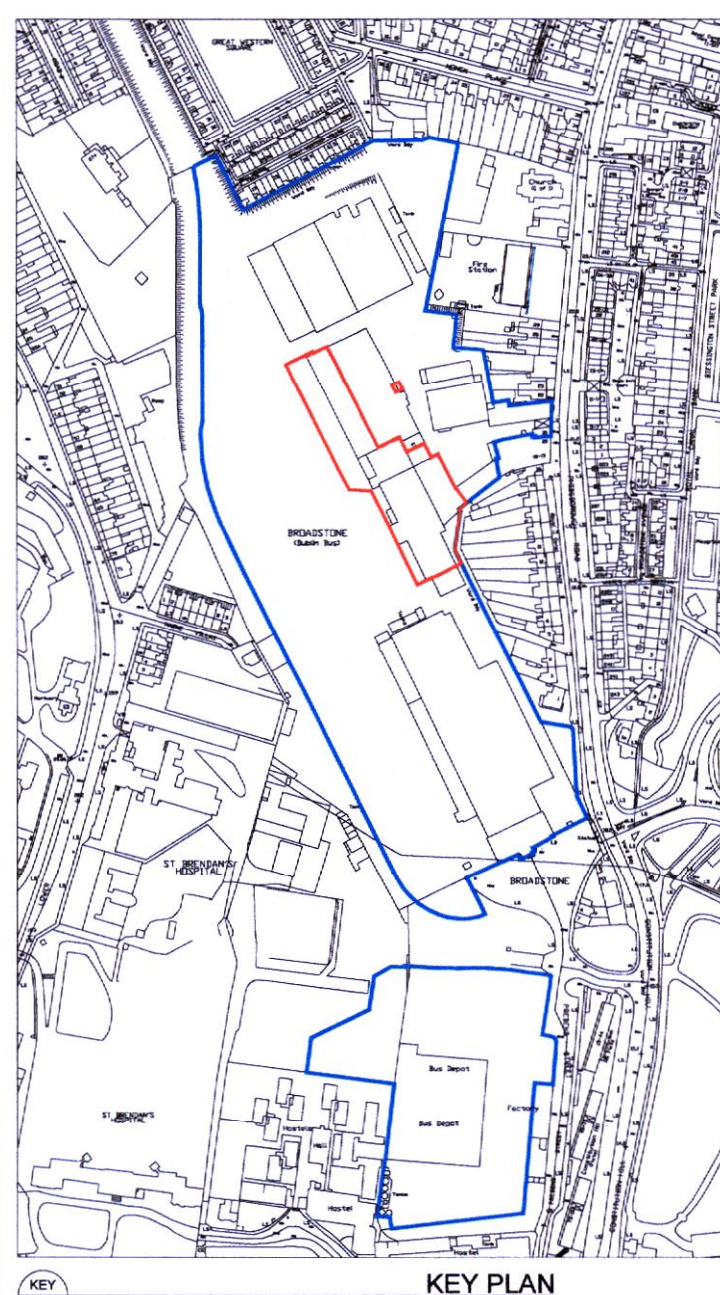

01 GROUND FLOOR PLAN - PROPOSED
BROADSTONE - FURNITURE STORE SCALE: 1:200 @ A1

KEY PLAN:

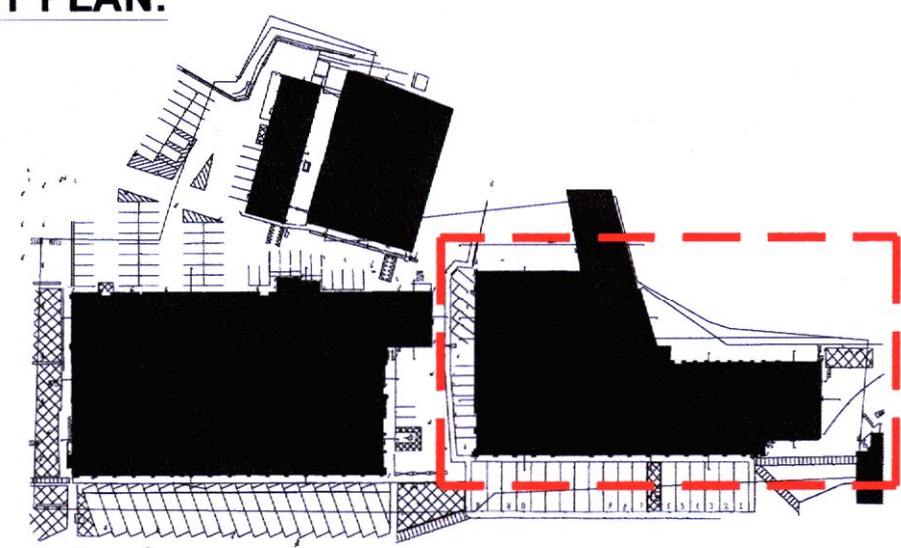

LEGEND:

- PROPOSED WORKS / INTERVENTION ARE INDICATED IN BLUE
- DISABLED REFUGE MIN. 1400mm X 900mm
 - DOOR GROUND FLOOR
 - NEW DOOR GROUND FLOOR
 - ROOM GROUND FLOOR
 - EXISTING DOOR TO BE REPLACED BY NEW DOOR
 - WINDOW GROUND FLOOR
 - NEW WINDOW GROUND FLOOR
 - ELECTRICAL RISERS


- PROPOSED LOCATIONS OF RETAINED EXISTING TIMBER DOORS
- WG-11
- NWG-01




REF IMAGE: STAINLESS STEEL SHEFFIELD BIKE STANDS



REF IMAGE: STAINLESS STEEL SHEFFIELD BIKE STANDS

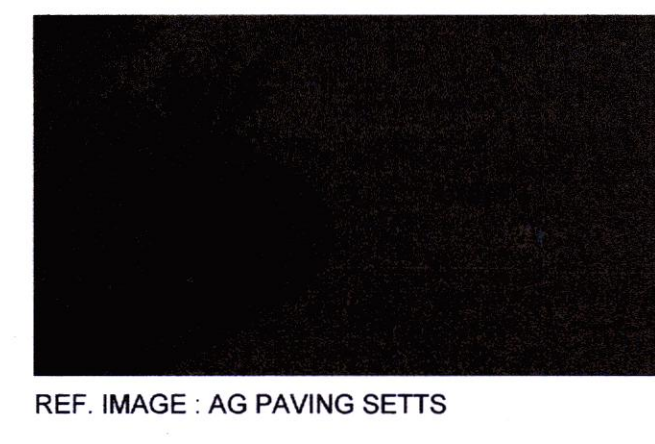


REF IMAGE: AG PAVING SETTS

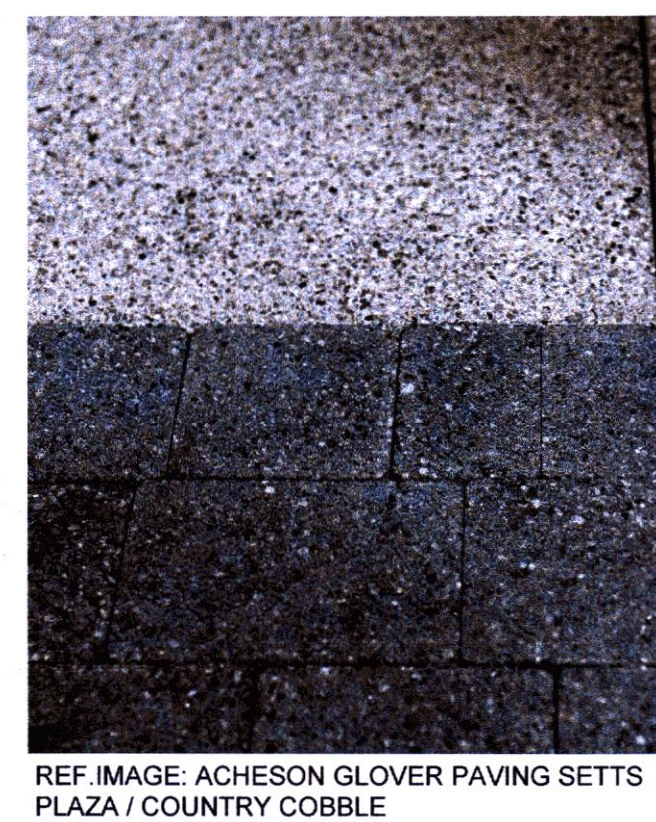

REF IMAGE: ACHESON GLOVER PAVING SETTS PLAZA / COUNTRY COBBLE



REF IMAGE: STAINLESS STEEL CARGO BIKES STANDS

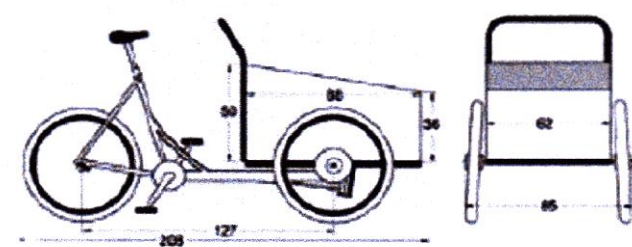

Scale 1:200
0 5 10 20

FURTHER INFORMATION TO PLANNING 3228/23

ADD. INFO 11/10/23
PLAN NO 3228/23

FURTHER INFORMATION

REVISION	DRAWN	DATE	COMMENT
REVISION: A	DRAWN: ZMM	DATE: 11.10.2023	Further information submitted
DRAWN: ZMM	CHECKED: SR	SURVEYED: FEBRUARY 2023	DATE: FEBRUARY 2023

NEW WORKS DIVISION
ARCHITECTS SECTION
ENGINEERING & NEW WORKS,
INCHICORE WORKS, DUBLIN 8.

BROADSTONE - DUBLIN BUS HQ FURNITURE STORE PROPOSED GROUND FLOOR PLAN

DRAWN	CHECKED	SR	JOB NO.	DATE
ZMM	SR		51.3.433	FEB 2023
SCALE	DRAWING NO.			
1:200 @ A1	51.3.433 - P21			

